


REV.	REVISIONS	DRWN.	DATE	APPROVD.
A	ADDED RELIEF VALVES 65 AND 66	N HUQUE	13AUG18	13AUG18

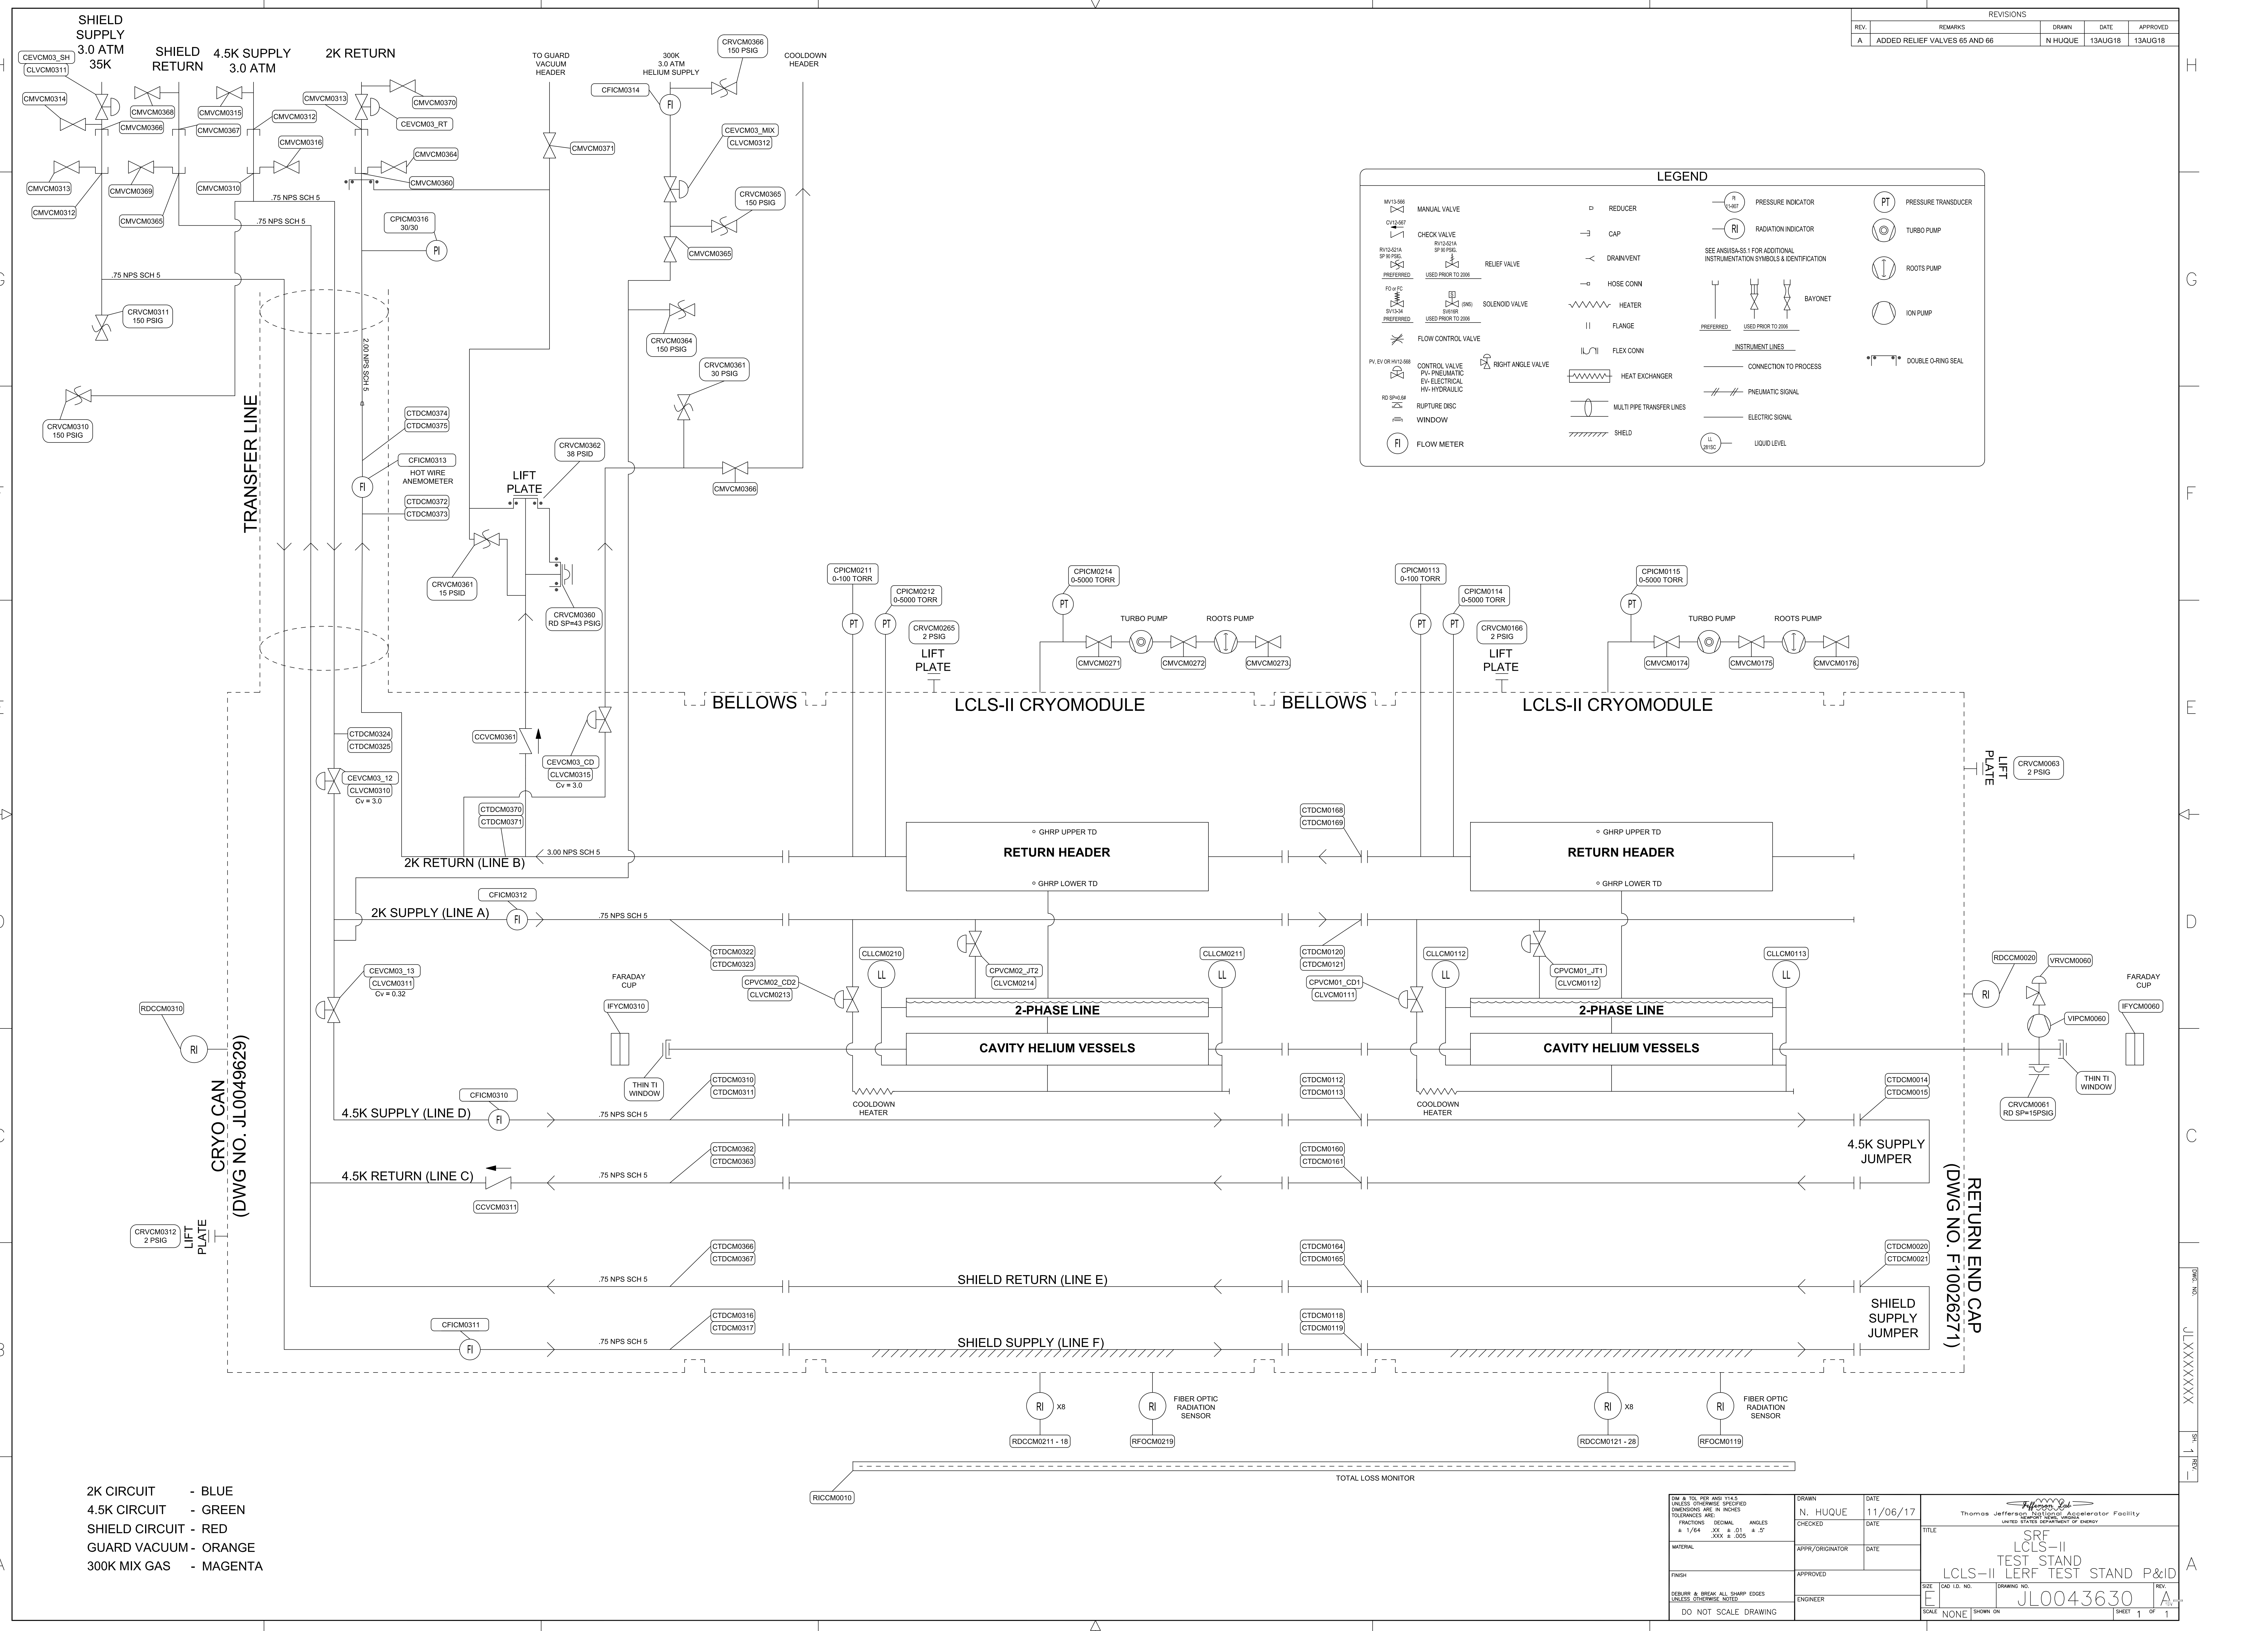

2K CIRCUIT - BLUE
 4.5K CIRCUIT - GREEN
 SHIELD CIRCUIT - RED
 GUARD VACUUM - ORANGE
 300K MIX GAS - MAGENTA

DWG. NO. JL0043630 SHEET 1 OF 1	DRAWN: N. HUQUE DATE: 11/06/17 CHECKED: _____ DATE: _____ APPR/ORIGINATOR: _____ DATE: _____ APPROVED: _____ ENGINEER: _____	TITLE: SRF LCLS-II TEST STAND LCLS-II LERF TEST STAND P&ID DRAWING NO. JL0043630 SHEET 1 OF 1
------------------------------------	---	---