


REVISIONS					
REV	ZONE	DESCRIPTION	DATE	APPROVALS	
0		RELEASE FOR DESIGN PER DEO# 2537	2/11/99		
1		RELEASE FOR MANUFACTURING PER DEO# 2836	2/15/91		
2		REVISED PER DEO #3505	5/31/91		
3		REVISED PER DEO #3938	8/26/91		
4		REVISED PER DEO #4641	2/5/92		
5		REVISED AS-BUILT DEO #5793	10/93		
6		REVISED: ADDED NOTE 3	5/7/19	CRB	CCP J.DW DMA

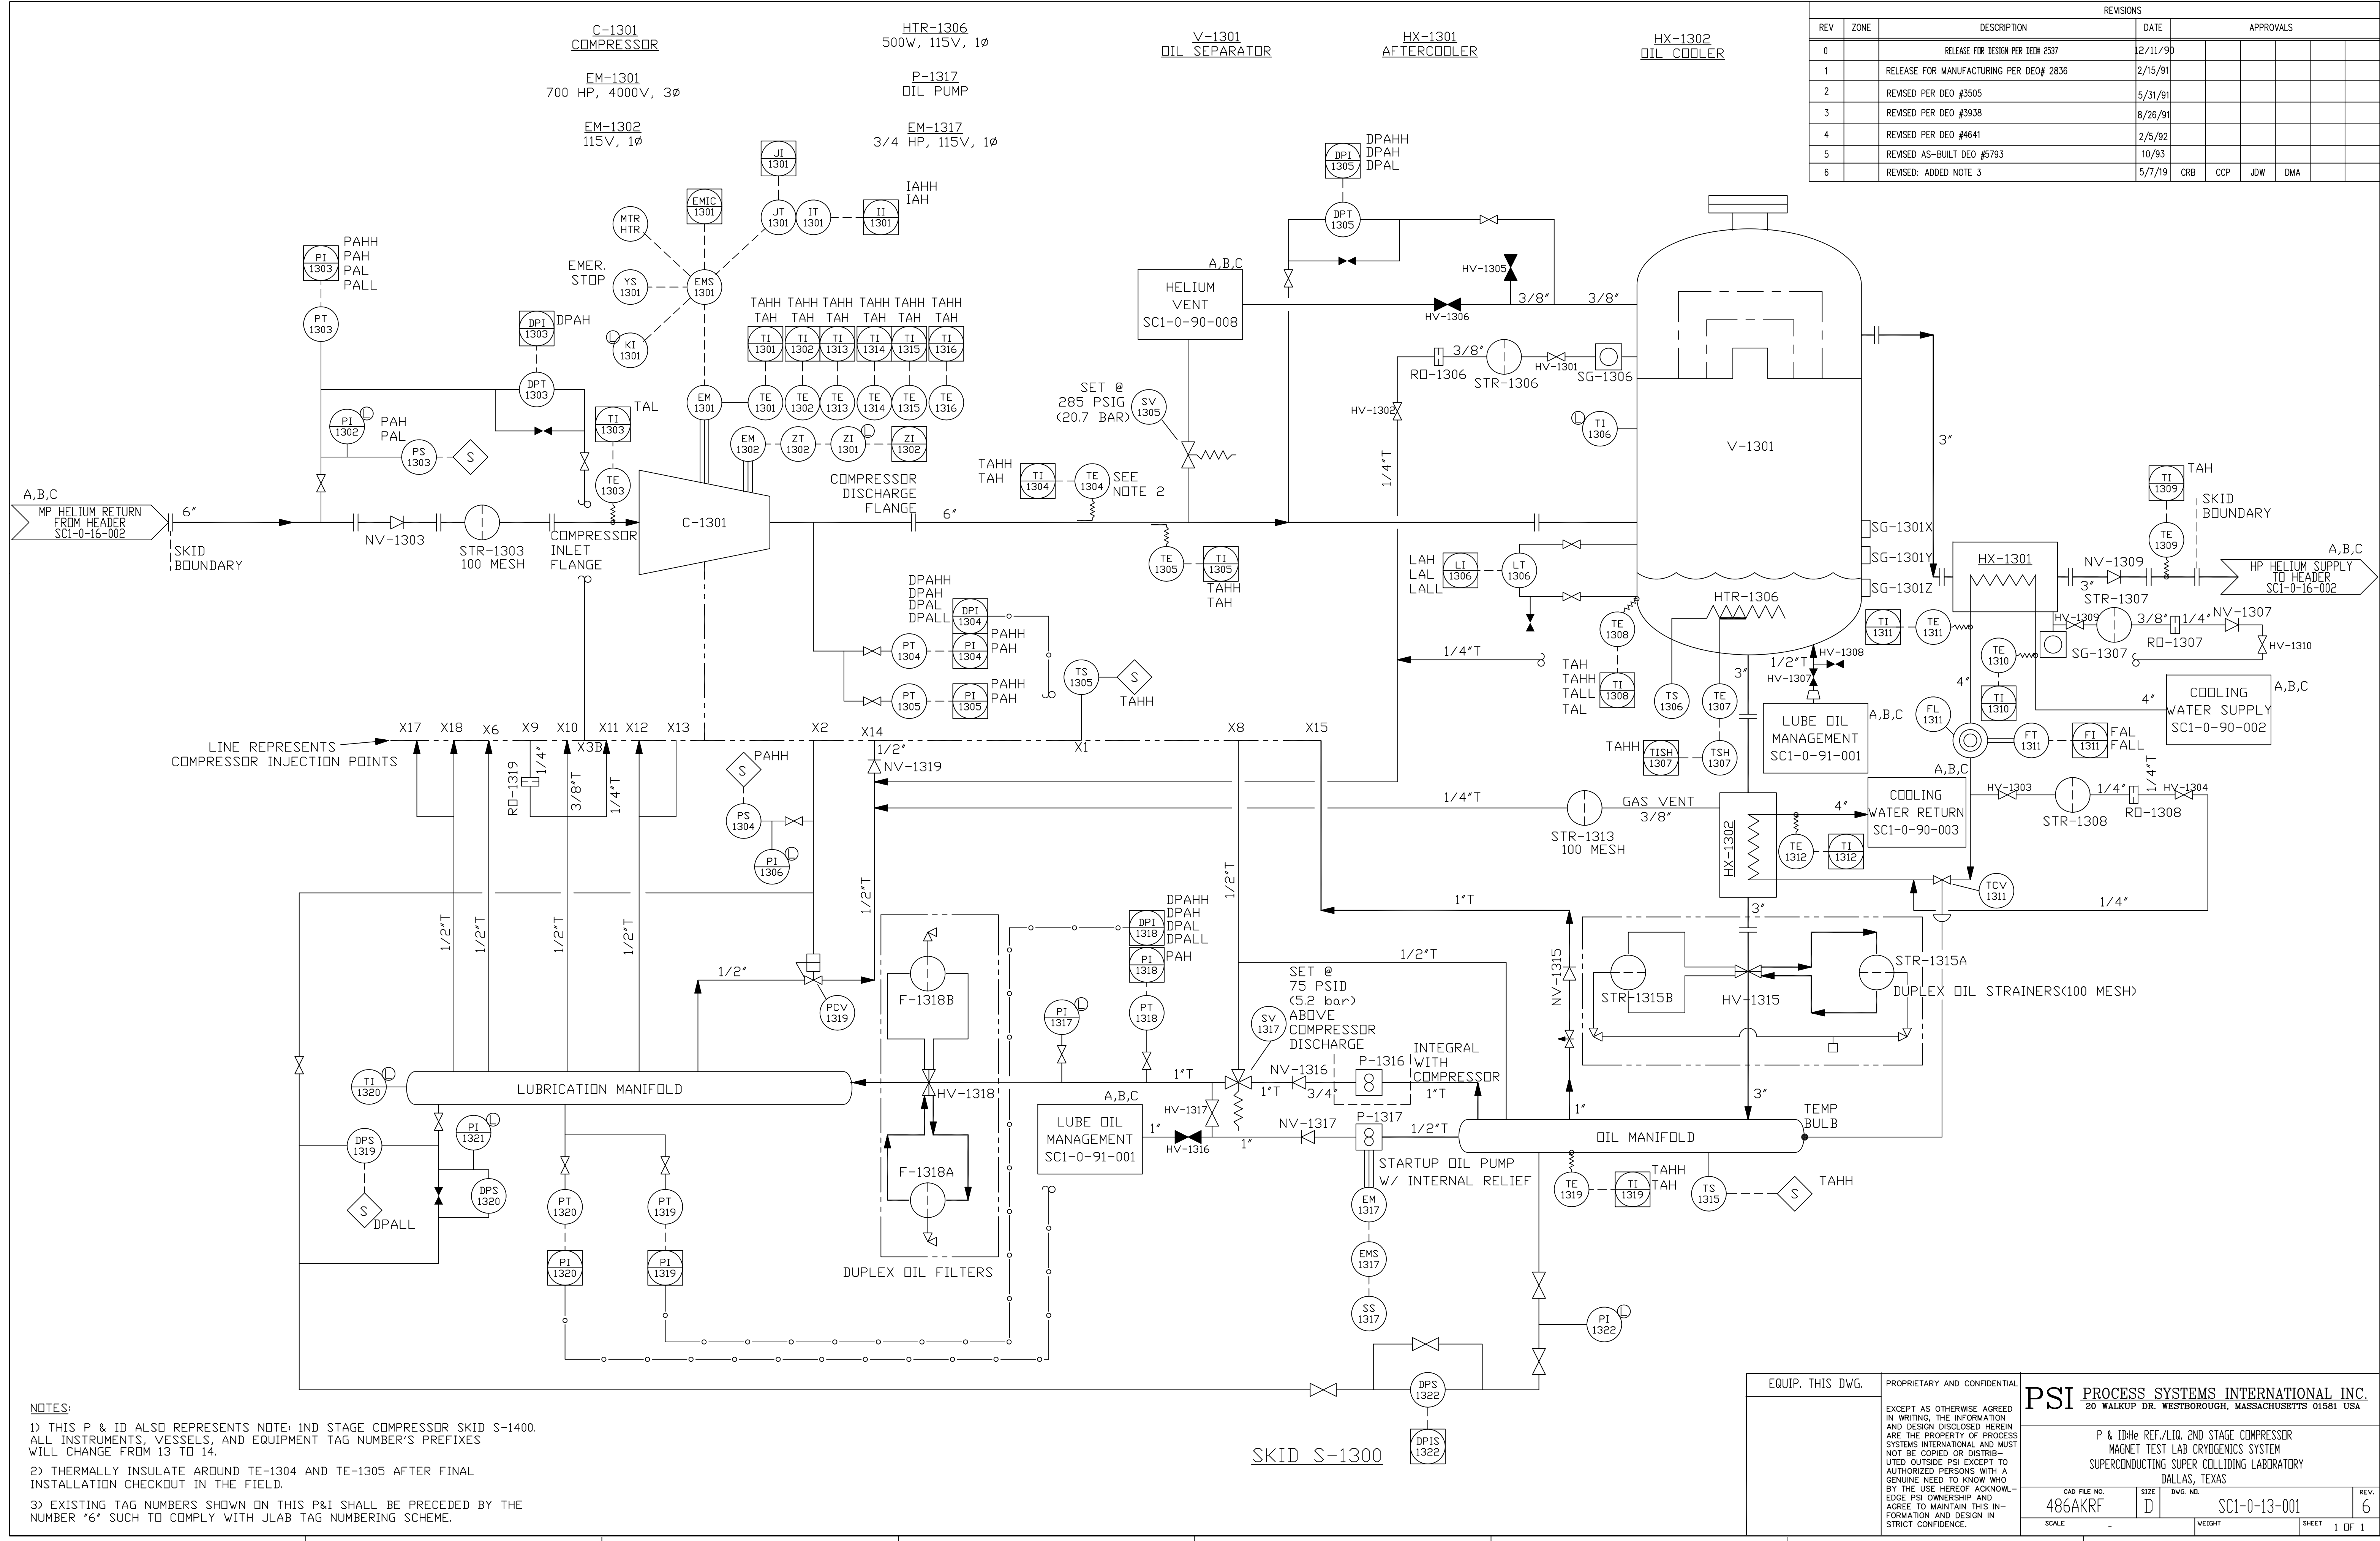

- NOTES:
- 1) THIS P & ID ALSO REPRESENTS NOTE: 1ND STAGE COMPRESSOR SKID S-1400. ALL INSTRUMENTS, VESSELS, AND EQUIPMENT TAG NUMBER'S PREFIXES WILL CHANGE FROM 13 TO 14.
  - 2) THERMALLY INSULATE AROUND TE-1304 AND TE-1305 AFTER FINAL INSTALLATION CHECKOUT IN THE FIELD.
  - 3) EXISTING TAG NUMBERS SHOWN ON THIS P&I SHALL BE PRECEDED BY THE NUMBER '6' SUCH TO COMPLY WITH JLAB TAG NUMBERING SCHEME.

EQUIP. THIS DWG.	PROPRIETARY AND CONFIDENTIAL	<b>PSI PROCESS SYSTEMS INTERNATIONAL INC.</b> 20 WALKUP DR. WESTBOROUGH, MASSACHUSETTS 01581 USA	
EXCEPT AS OTHERWISE AGREED IN WRITING, THE INFORMATION AND DESIGN DISCLOSED HEREIN ARE THE PROPERTY OF PROCESS SYSTEMS INTERNATIONAL AND MUST NOT BE COPIED OR DISTRIBUTED OUTSIDE PSI EXCEPT TO AUTHORIZED PERSONS WITH A GENUINE NEED TO KNOW WHO BY THE USE HEREOF ACKNOWLEDGE PSI OWNERSHIP AND AGREE TO MAINTAIN THIS INFORMATION AND DESIGN IN STRICT CONFIDENCE.		P & ID# REF./LID. 2ND STAGE COMPRESSOR MAGNET TEST LAB CRYOGENICS SYSTEM SUPERCONDUCTING SUPER COLLIDING LABORATORY DALLAS, TEXAS	
CAO FILE NO. 486AKRF	SIZE D	DWG. NO. SC1-0-13-001	REV. 6
SCALE	WEIGHT	SHEET	1 OF 1